


① 現道 2 現道(分離) 3 旧道 4 新道 5 専用自歩道

平面図 縮尺千分の一

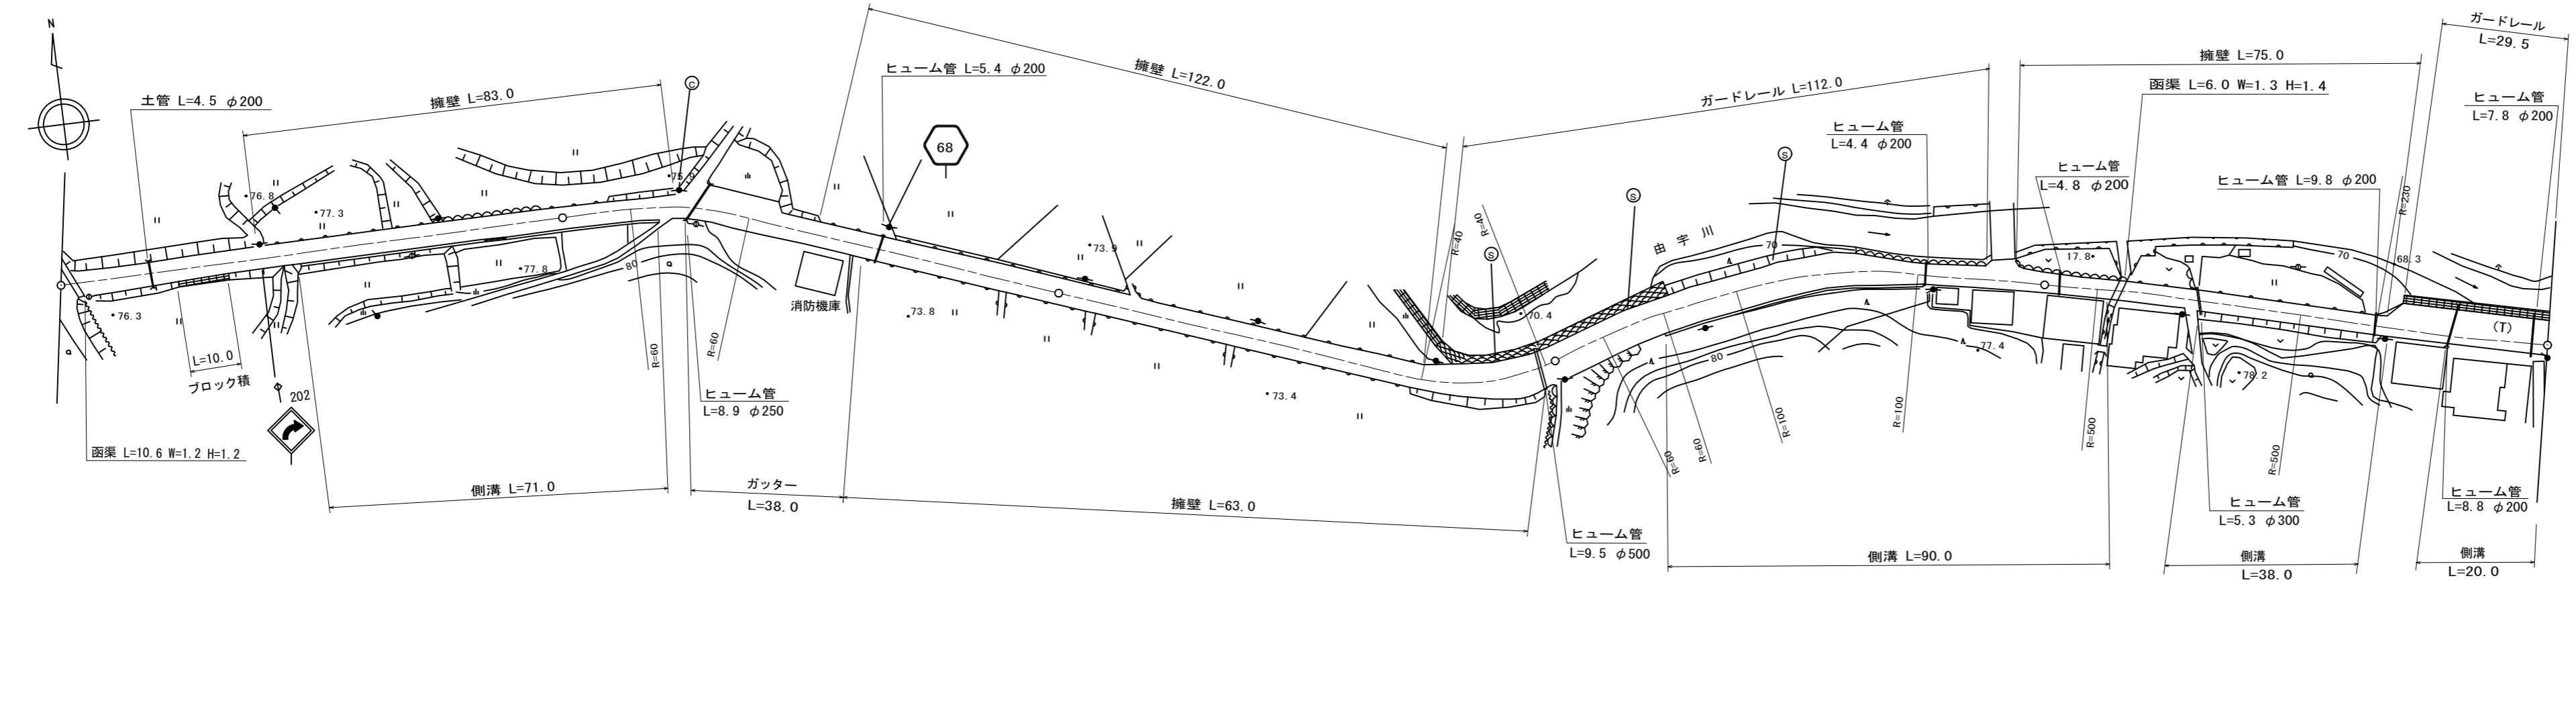

道路台帳修正履歴

カルテ番号	修正内容	調整年月日	業者名
	転記	1982. 3. 31	イワキ測量設計
2018-04-013	ラス・ベク変換 消防機庫新築	2019. 3. 31	泉土木コ

区間番号	100.0																					200.0																					300.0																					400.0																					500.0																																													
	1	2	3	4	5	6	7	8	9	10	11	12	13	14	15	16	17	18	19	20	21	1	2	3	4	5	6	7	8	9	10	11	12	13	14	15	16	17	18	19	20	21	1	2	3	4	5	6	7	8	9	10	11	12	13	14	15	16	17	18	19	20	21	1	2	3	4	5	6	7	8	9	10	11	12	13	14	15	16	17	18	19	20	21	1	2	3	4	5	6	7	8	9	10	11	12	13	14	15	16	17	18	19	20	21																									
点間距離	47.5		52.5	19.0	5.0	4.0	19.0		53.0		71.5	20.5	8.0	22.0		36.5	17.0	13.0	11.5	12.5	18.5		37.0	2.5	9.5	20.0	47.5		52.5	19.0	5.0	4.0	19.0		53.0		71.5	20.5	8.0	22.0		36.5	17.0	13.0	11.5	12.5	18.5		37.0	2.5	9.5	20.0	47.5		52.5	19.0	5.0	4.0	19.0		53.0		71.5	20.5	8.0	22.0		36.5	17.0	13.0	11.5	12.5	18.5		37.0	2.5	9.5	20.0	47.5		52.5	19.0	5.0	4.0	19.0		53.0		71.5	20.5	8.0	22.0		36.5	17.0	13.0	11.5	12.5	18.5		37.0	2.5	9.5	20.0	47.5		52.5	19.0	5.0	4.0	19.0		53.0		71.5	20.5	8.0	22.0		36.5	17.0	13.0	11.5	12.5	18.5		37.0	2.5	9.5	20.0
全幅員	4.5	4.0	4.0	4.0	5.0	7.0	5.0	5.0	5.0	7.0	7.0	7.0	7.0	7.0	7.0	4.5	4.0	3.76	3.5	3.5	3.5		3.5	6.0	6.6	6.6	4.5	4.0	4.0	4.0	5.0	7.0	5.0	5.0	5.0	5.0	7.0	7.0	7.0	7.0	7.0	4.5	4.0	3.76	3.5	3.5	3.5		3.5	6.0	6.6	6.6	4.5	4.0	4.0	4.0	5.0	7.0	5.0	5.0	5.0	5.0	7.0	7.0	7.0	7.0	7.0	4.5	4.0	3.76	3.5	3.5	3.5		3.5	6.0	6.6	6.6	4.5	4.0	4.0	4.0	5.0	7.0	5.0	5.0	5.0	5.0	7.0	7.0	7.0	7.0	7.0	4.5	4.0	3.76	3.5	3.5	3.5		3.5	6.0	6.6	6.6	4.5	4.0	4.0	4.0	5.0	7.0	5.0	5.0	5.0	5.0	7.0	7.0	7.0	7.0	7.0	4.5	4.0	3.76	3.5	3.5	3.5		3.5	6.0	6.6	6.6
全幅員内訳	車道	3.5	3.0	3.0	3.0	4.0	4.0	4.0	4.0	4.0	4.0	4.0	4.0	4.0	4.0	3.5	3.0	2.76	2.5	2.5	2.5		2.5	2.5	2.5	2.5	3.5	3.0	3.0	3.0	4.0	4.0	4.0	4.0	4.0	4.0	4.0	4.0	4.0	4.0	3.5	3.0	2.76	2.5	2.5	2.5		2.5	2.5	2.5	2.5	3.5	3.0	3.0	3.0	4.0	4.0	4.0	4.0	4.0	4.0	4.0	4.0	4.0	4.0	4.0	3.5	3.0	2.76	2.5	2.5	2.5		2.5	2.5	2.5	2.5	3.5	3.0	3.0	3.0	4.0	4.0	4.0	4.0	4.0	4.0	4.0	4.0	4.0	4.0	4.0	3.5	3.0	2.76	2.5	2.5	2.5		2.5	2.5	2.5	2.5	3.5	3.0	3.0	3.0	4.0	4.0	4.0	4.0	4.0	4.0	4.0	4.0	4.0	4.0	4.0	3.5	3.0	2.76	2.5	2.5	2.5		2.5	2.5	2.5	2.5	
	左側歩道																																																																																																																																	
	右側歩道																																																																																																																																	
	左側路肩	0.5	0.5	右側路肩	0.5	0.5	中央分離帯																																																																																																																																		
側溝		0.0	0.3	0.3	0.0						0.0			0.3		0.3	0.3	0.3	0.3	0.3	0.0	0.3		0.3	0.0	0.0	0.0		0.0	0.3	0.3	0.0						0.0		0.3		0.3	0.3	0.3	0.3	0.0	0.3		0.3	0.0	0.0	0.0		0.0	0.3	0.3	0.0						0.0		0.3		0.3		0.3	0.3	0.3	0.3	0.0	0.3		0.3	0.0	0.0	0.0		0.0	0.3	0.3	0.0						0.0		0.3		0.3		0.3	0.3	0.3	0.3	0.0	0.3		0.3	0.0	0.0	0.0																								
その他																																																																																																																																		
主要工物																																																																																																																																		
路面種別	as																								as																									as																									as																									as																														
舗装区間番号	1	2	3	4	5																			1	2	3	4	5																				1	2	3	4	5																				1	2	3	4	5																				1	2	3	4	5																														

路線名	主要地方道光日積線
図面名	206804038-00
作成年月日	2019年3月31日
縮尺	1/1000
図面番号	038-00
事務所名	山口県柳井土木建築事務所